

AJ BALA
BLOCK 1 SECTION 67




Figured Dimensions to be used in preference to scaled measurements.
Contractor must verify all dimensions on site.

 

Copyright:
This document is and shall remain the property of **Geoffrey Schier**
This document may only be used for the purpose for which it was commissioned \$ in accordance with the terms of engagement for the commission.
Unauthorised use of this document in anyway is prohibited. (c)


Amendments		
No	Description	Date

GS	AB	100 SERIES - SITE PLANS	GS	AB	500 SERIES - DETAILS
		A101 SITE PLAN			A501 - WALL DETAIL
		A102 LANSCAPE PLAN			
		A103 SITE ANALYSIS			600 SERIES - SPECIALIST PLANS
					A601 - SLAB SET-OUT PLAN
		200 SERIES - FLOOR PLANS			A602 - REFLECTIVE CEILING PLAN/ELECTRICAL
		A201 GROUND FLOOR PLAN			
		A202 FIRST FLOOR PLAN			
		A203 ROOF PLAN			
		300 SERIES - ELEVATIONS			
		A301 - SOUTH ELEVATIONS			
		A302 - WEST ELEVATIONS			
		A303 - NORTH ELEVATIONS			
		400 SERIES - SECTIONS			
		A401 - SECTION 1 (EAST)			
		A402 - SECTION 2 (NORTH)			

Drawn By Geoffrey Schier	Verified By AJ Bala
Designed By CIT	Date Drawn 7.06.14
Authorised By	
Company Details & Logo	
 TREELIGHT DESIGN	
Client Details AJ Bala Block 1 Section 67 (589 sqm)	
Project Name Residential Development - Casey	
Drawing Title Drawing Schedule	
Scale 1:1	Date 18.06.14
Project No. A1	Issue 1
Drawing No. AOO	



GROUND FLOOR	156.3(sqm)
GARAGE 	32(sqm)
UPPER FLOOR 	90.6(sqm)
TOTAL	278.9 (47% GFA)

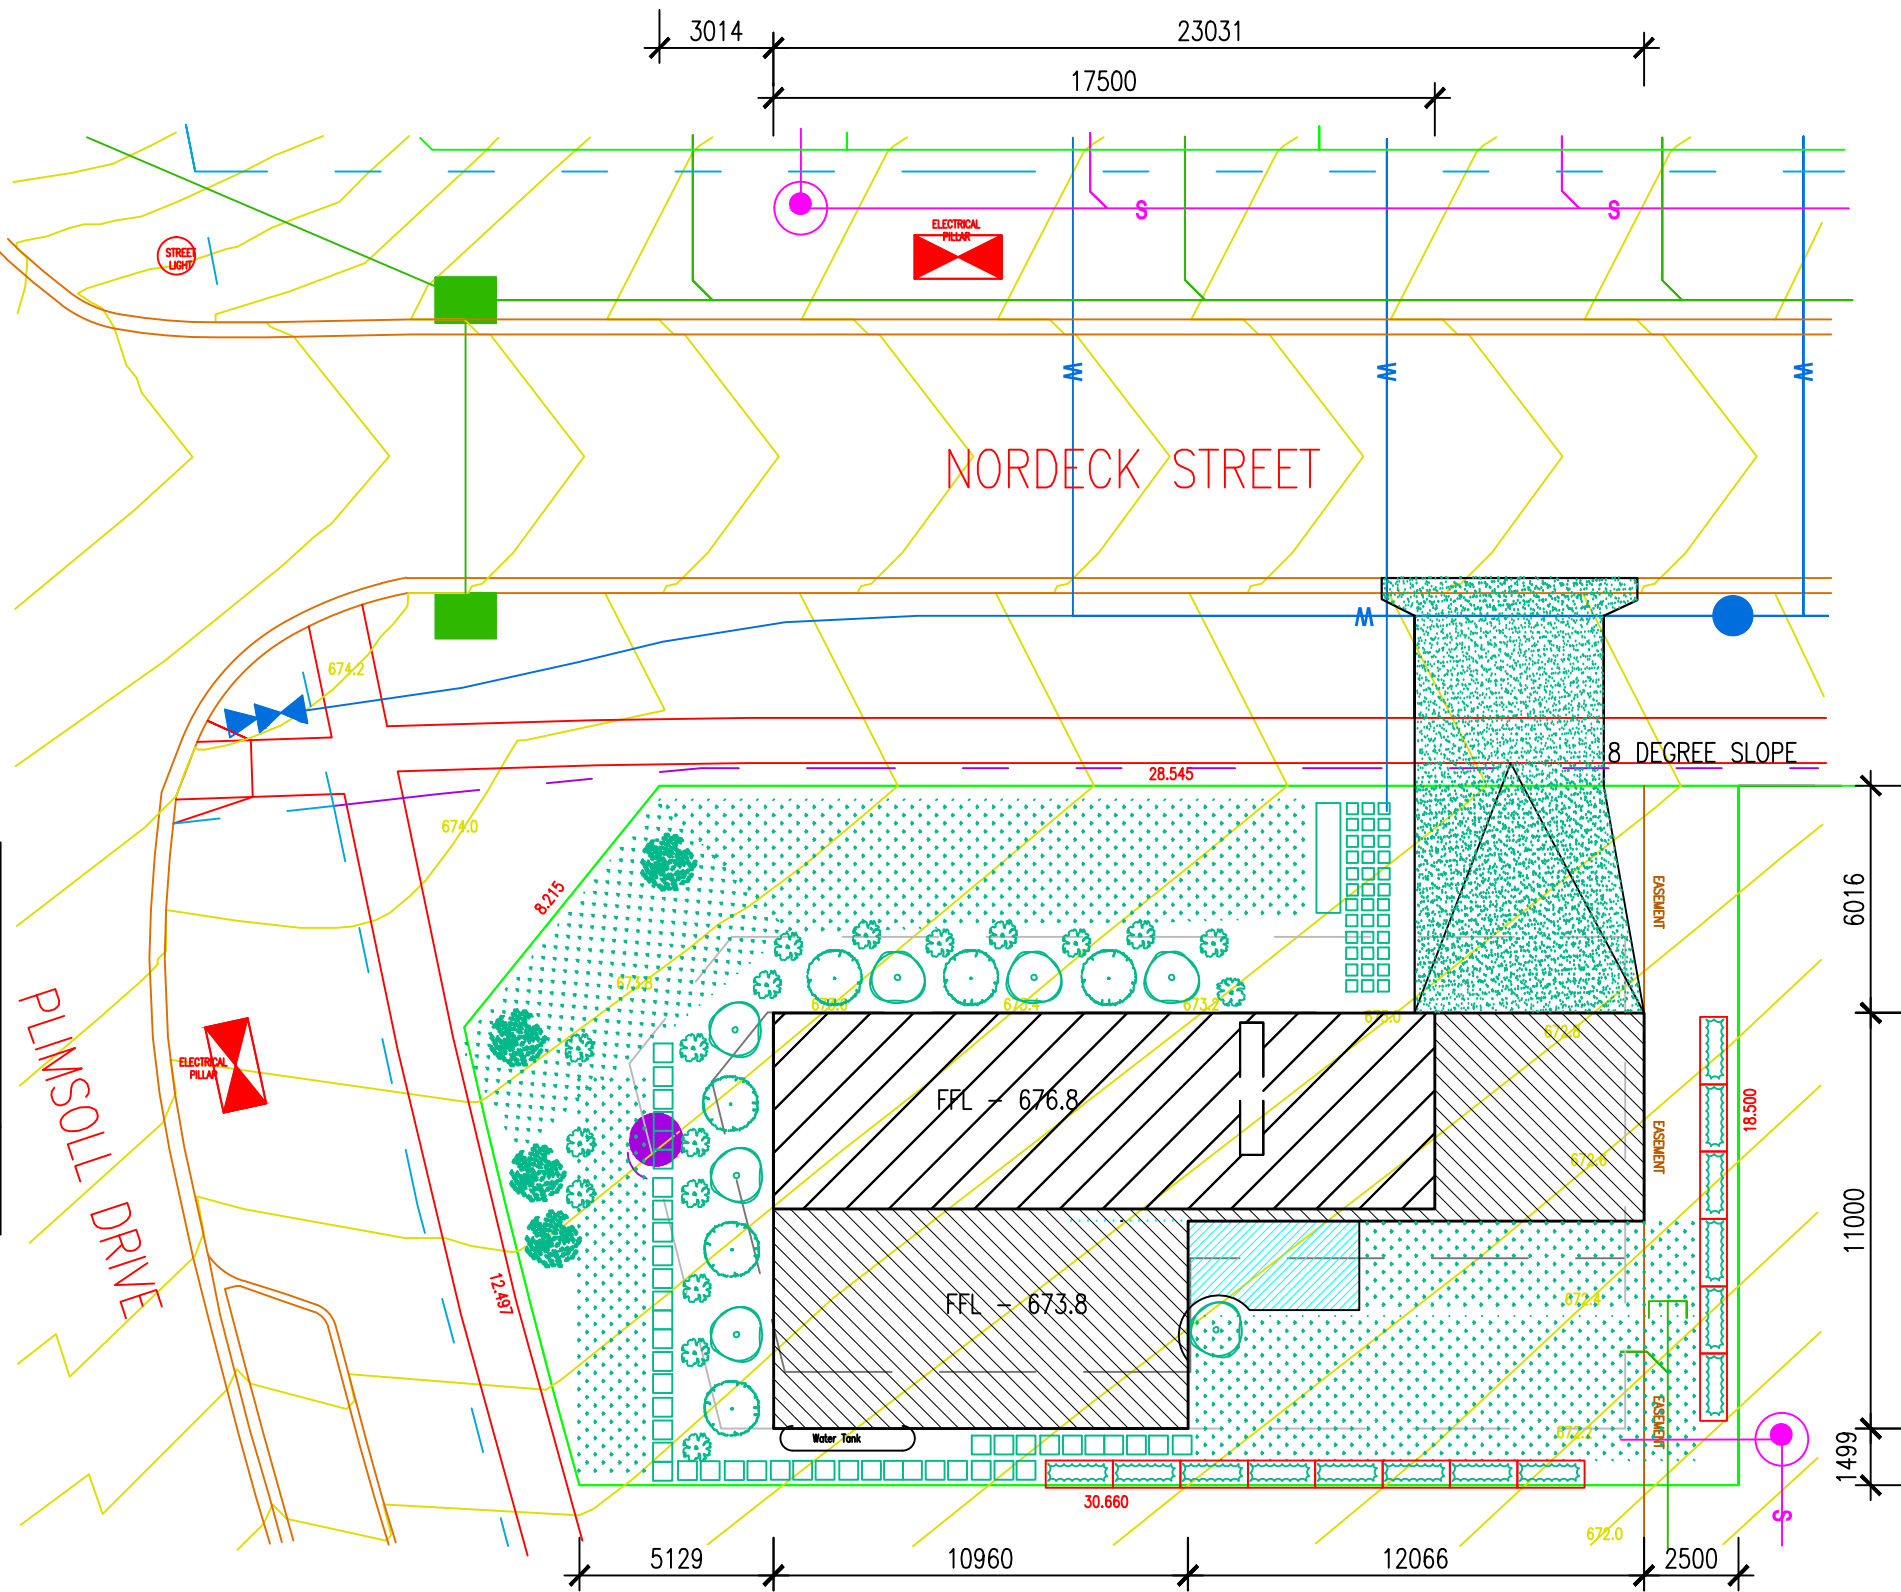

Figured Dimensions to be used in preference to scaled measurements.
Contractor must verify all dimensions on site.

Copyright:
This document is and shall remain the property of **Geoffrey Schier**
This document may only be used for the purpose for which it was commissioned \$ in accordance with the terms of engagement for the commission.
Unauthorised use of this document in anyway is prohibited. (c)

Amendments		
No	Description	Date

Drawn By Geoffrey Schier	Verified By AJ Bala
Designed By CIT	Date Drawn 7.06.2014

Authorised By

Company Details & Logo




Client Details
AJ Bala
Block 1 Section 67
(589 sqm)

Project Name
Residential Development - Casey

Drawing Title
Site Plan

Scale 1:200	Date 18.06.14	Drawing No.
Project No. A1	Issue 1	A101

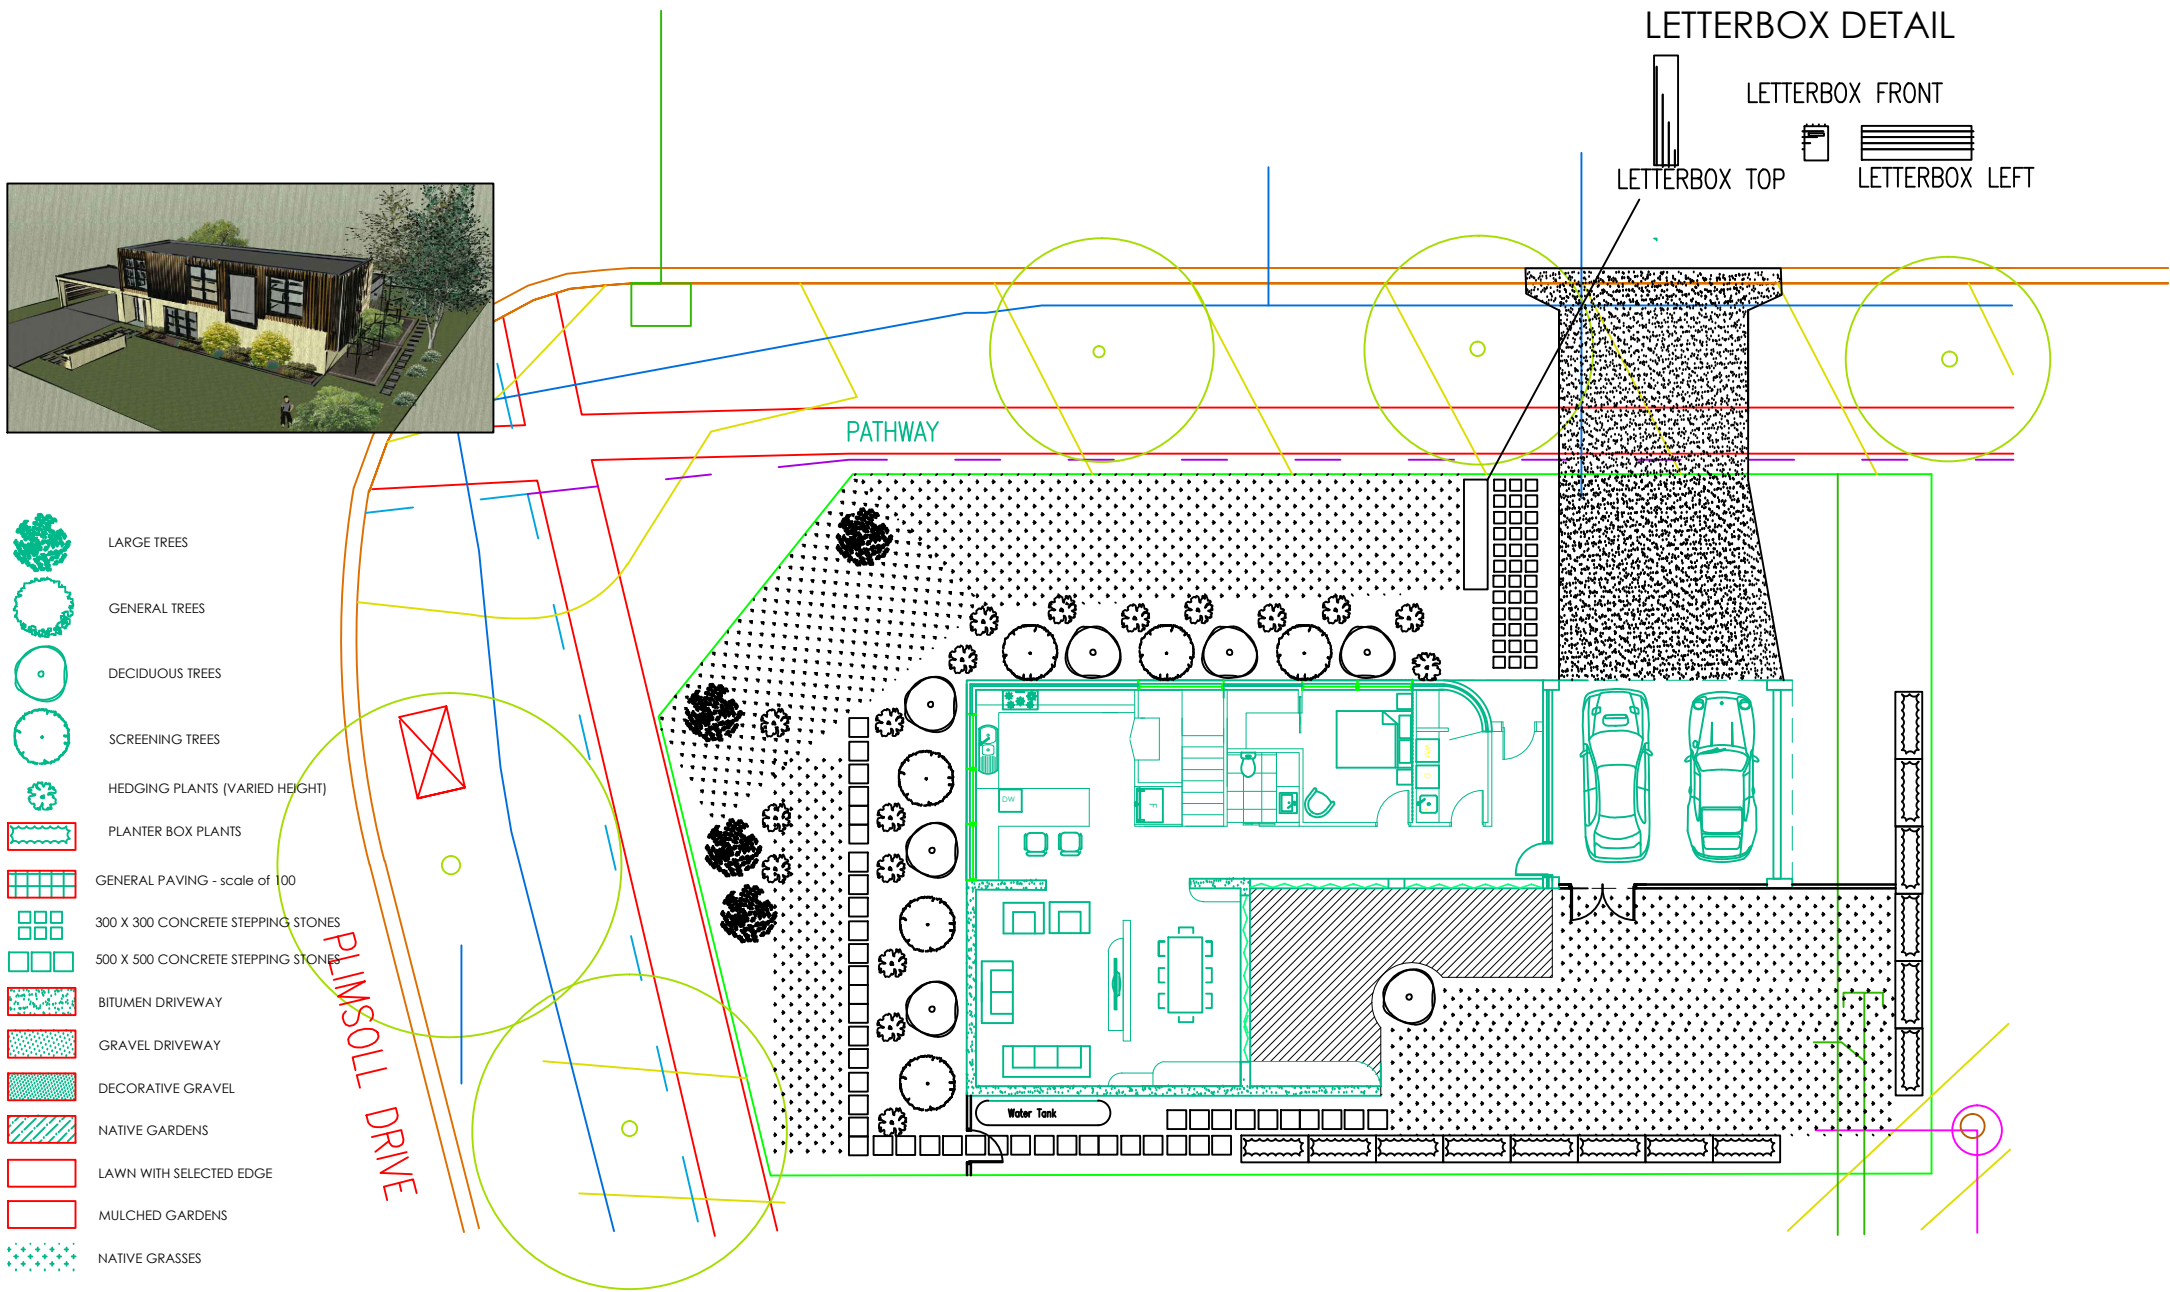

Figured Dimensions to be used in preference to scaled measurements.
Contractor must verify all dimensions on site.

Copyright:
This document is and shall remain the property of **Geoffrey Schier**
This document may only be used for the purpose for which it was commissioned \$ in accordance with the terms of engagement for the commission.
Unauthorised use of this document in anyway is prohibited. (c)

Amendments		
No	Description	Date

Drawn By Geoffrey Schier	Verified By AJ Bala
Designed By CIT	Date Drawn 21.05.2014
Authorised By	

Company Details & Logo

Client Details

AJ Bala
Block 1 Section 67
(589 sqm)

Project Name Residential Development - Casey		
Drawing Title Landscape Plan		

Scale 1:200	Date 18.06.14	Drawing No.
Project No. A1	Issue 1	A102



Figured Dimensions to be used in preference to scaled measurements.
Contractor must verify all dimensions on site.

Copyright:

This document is and shall remain the property of
Geoffrey Schier
This document may only be used for the purpose for which it was commissioned \$ in accordance with the terms of engagement for the commission.
Unauthorised use of this document in anyway is prohibited. (c)

Amendments		
No	Description	Date

Drawn By Geoffrey Schier	Verified By AJ Bala
Designed By CIT	Date Drawn 21.05.2014

Authorised By

Company Details &
Logo




Client Details
AJ Bala
Block 1 Section 67
(589 sqm)

Project Name
Residential Development - Casey

Drawing Title
Floor Plan Ground

Scale 1:100	Date 18.06.14	Drawing No.
Project No. A1	Issue 1	A201

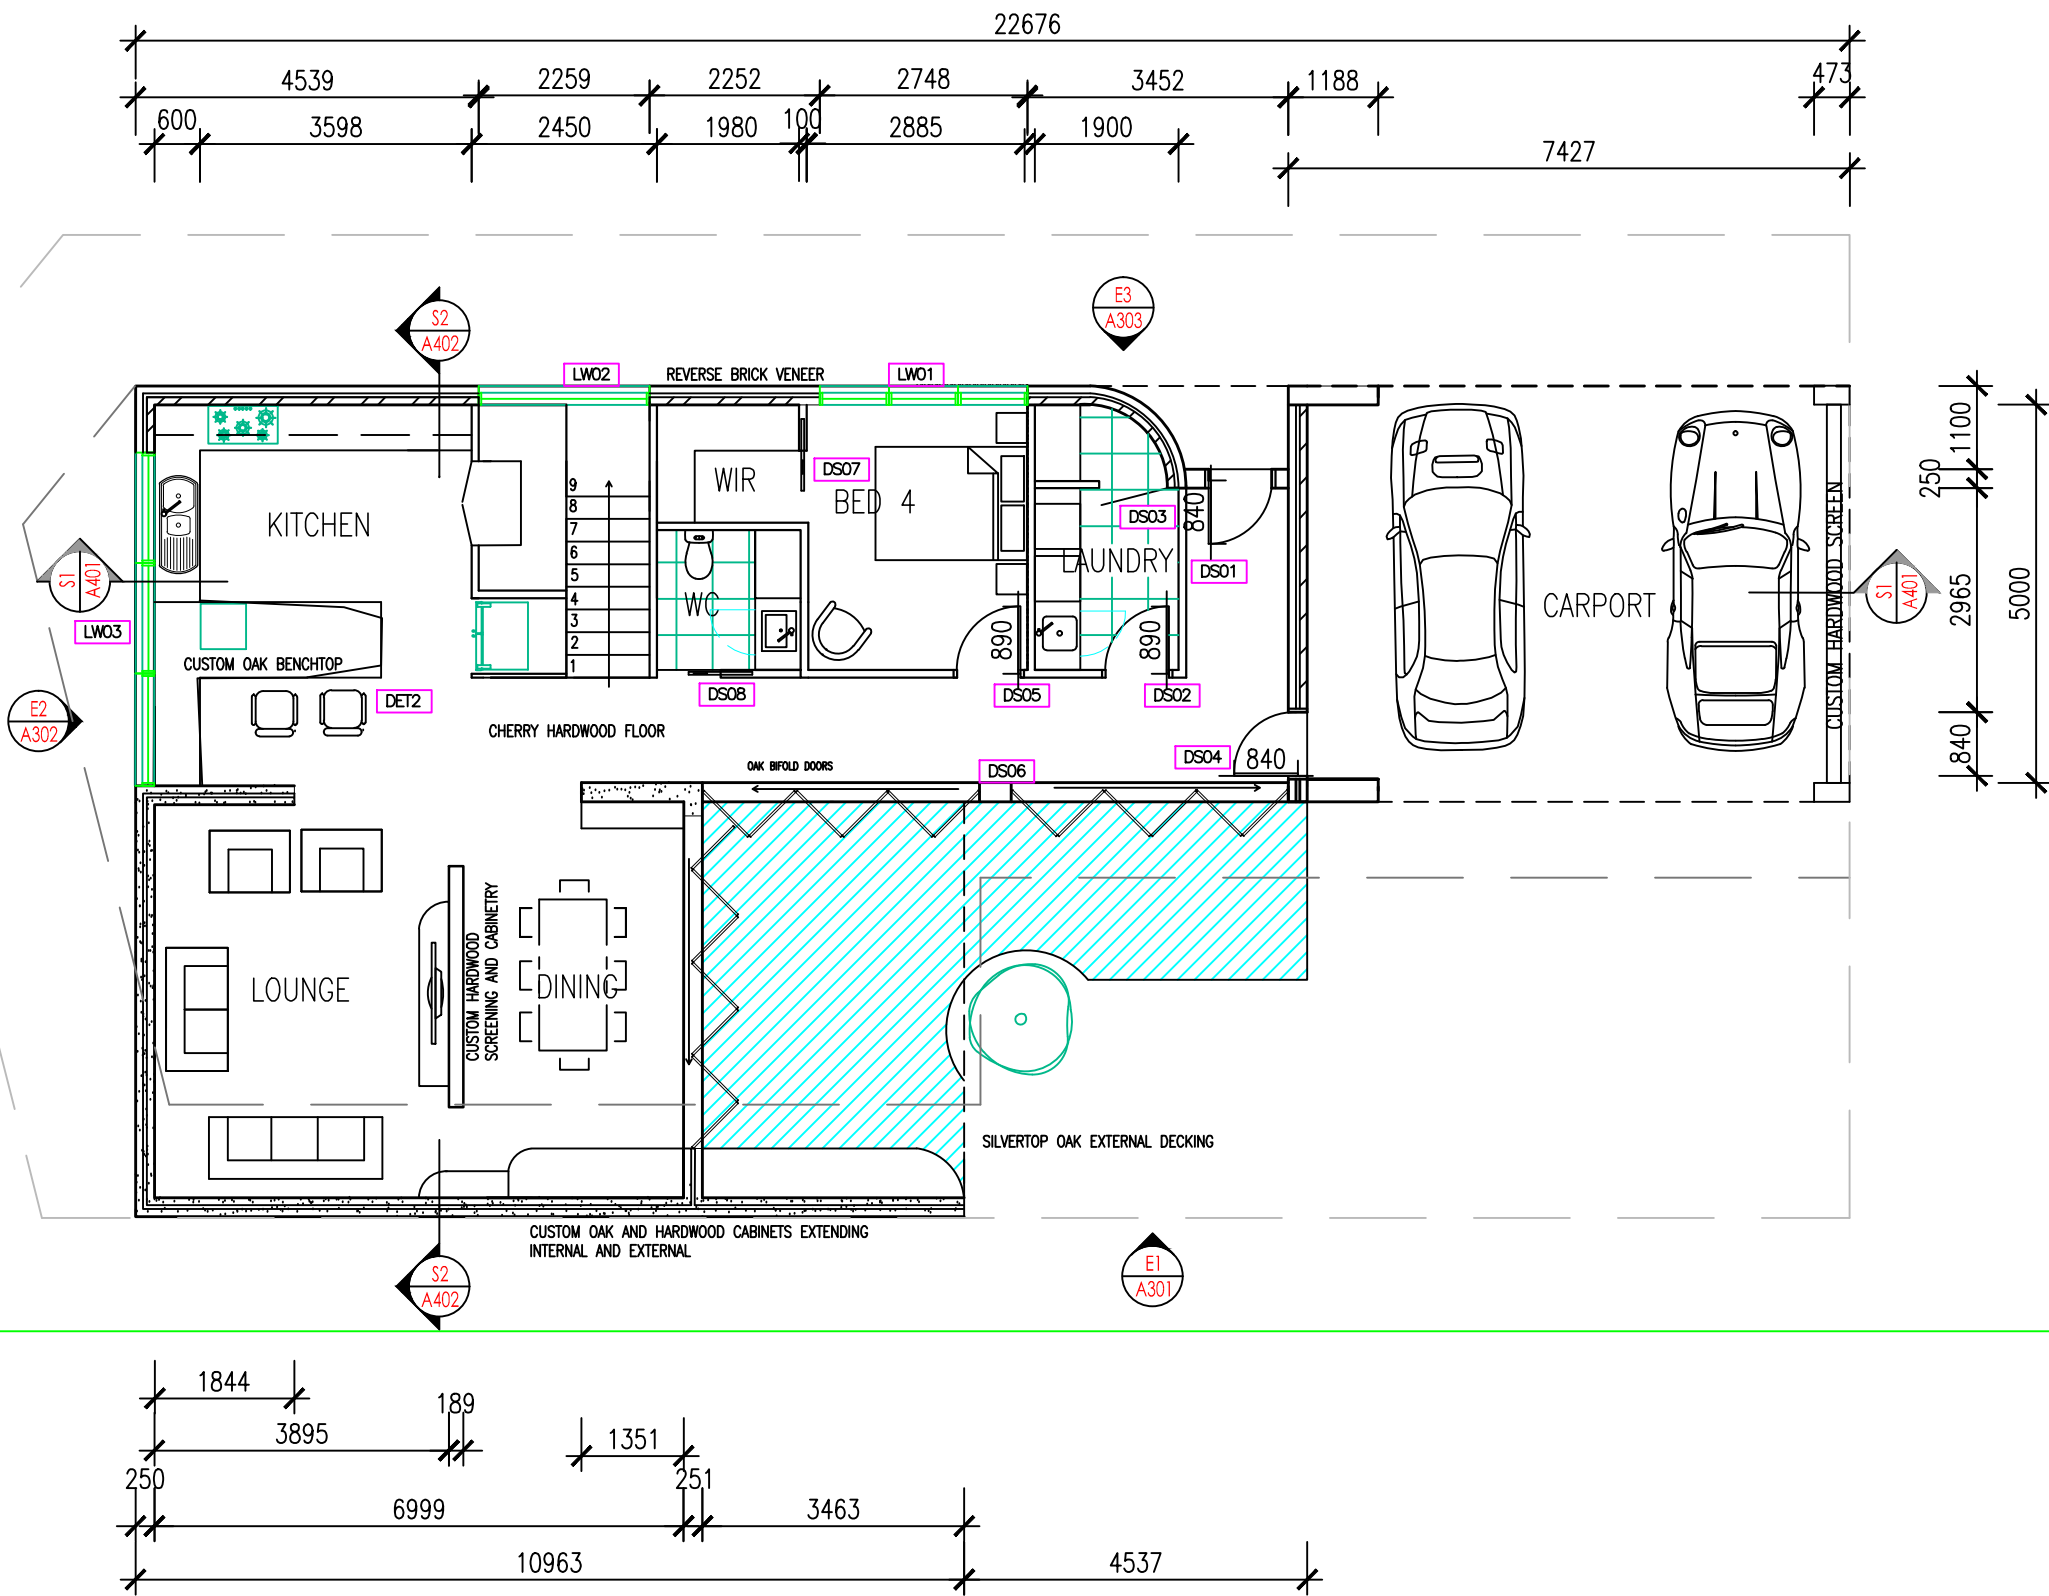



Figured Dimensions to be used in preference to scaled measurements.
Contractor must verify all dimensions on site.


Copyright:
This document is and shall remain the property of **Geoffrey Schier**
This document may only be used for the purpose for which it was commissioned \$ in accordance with the terms of engagement for the commission.
Unauthorised use of this document in anyway is prohibited. (c)

Amendments		
No	Description	Date

Drawn By Geoffrey Schier	Verified By AJ Bala
Designed By CIT	Date Drawn 21.05.2014

Authorised By

Company Details & Logo




TREELIGHT DESIGN


Client Details
AJ Bala
Block 1 Section 67
(589 sqm)

Project Name
Residential Development - Casey

Drawing Title
Floor Plan Upper


Scale 1:100	Date 18.06.14	Drawing No.
Project No. A1	Issue 1	A202

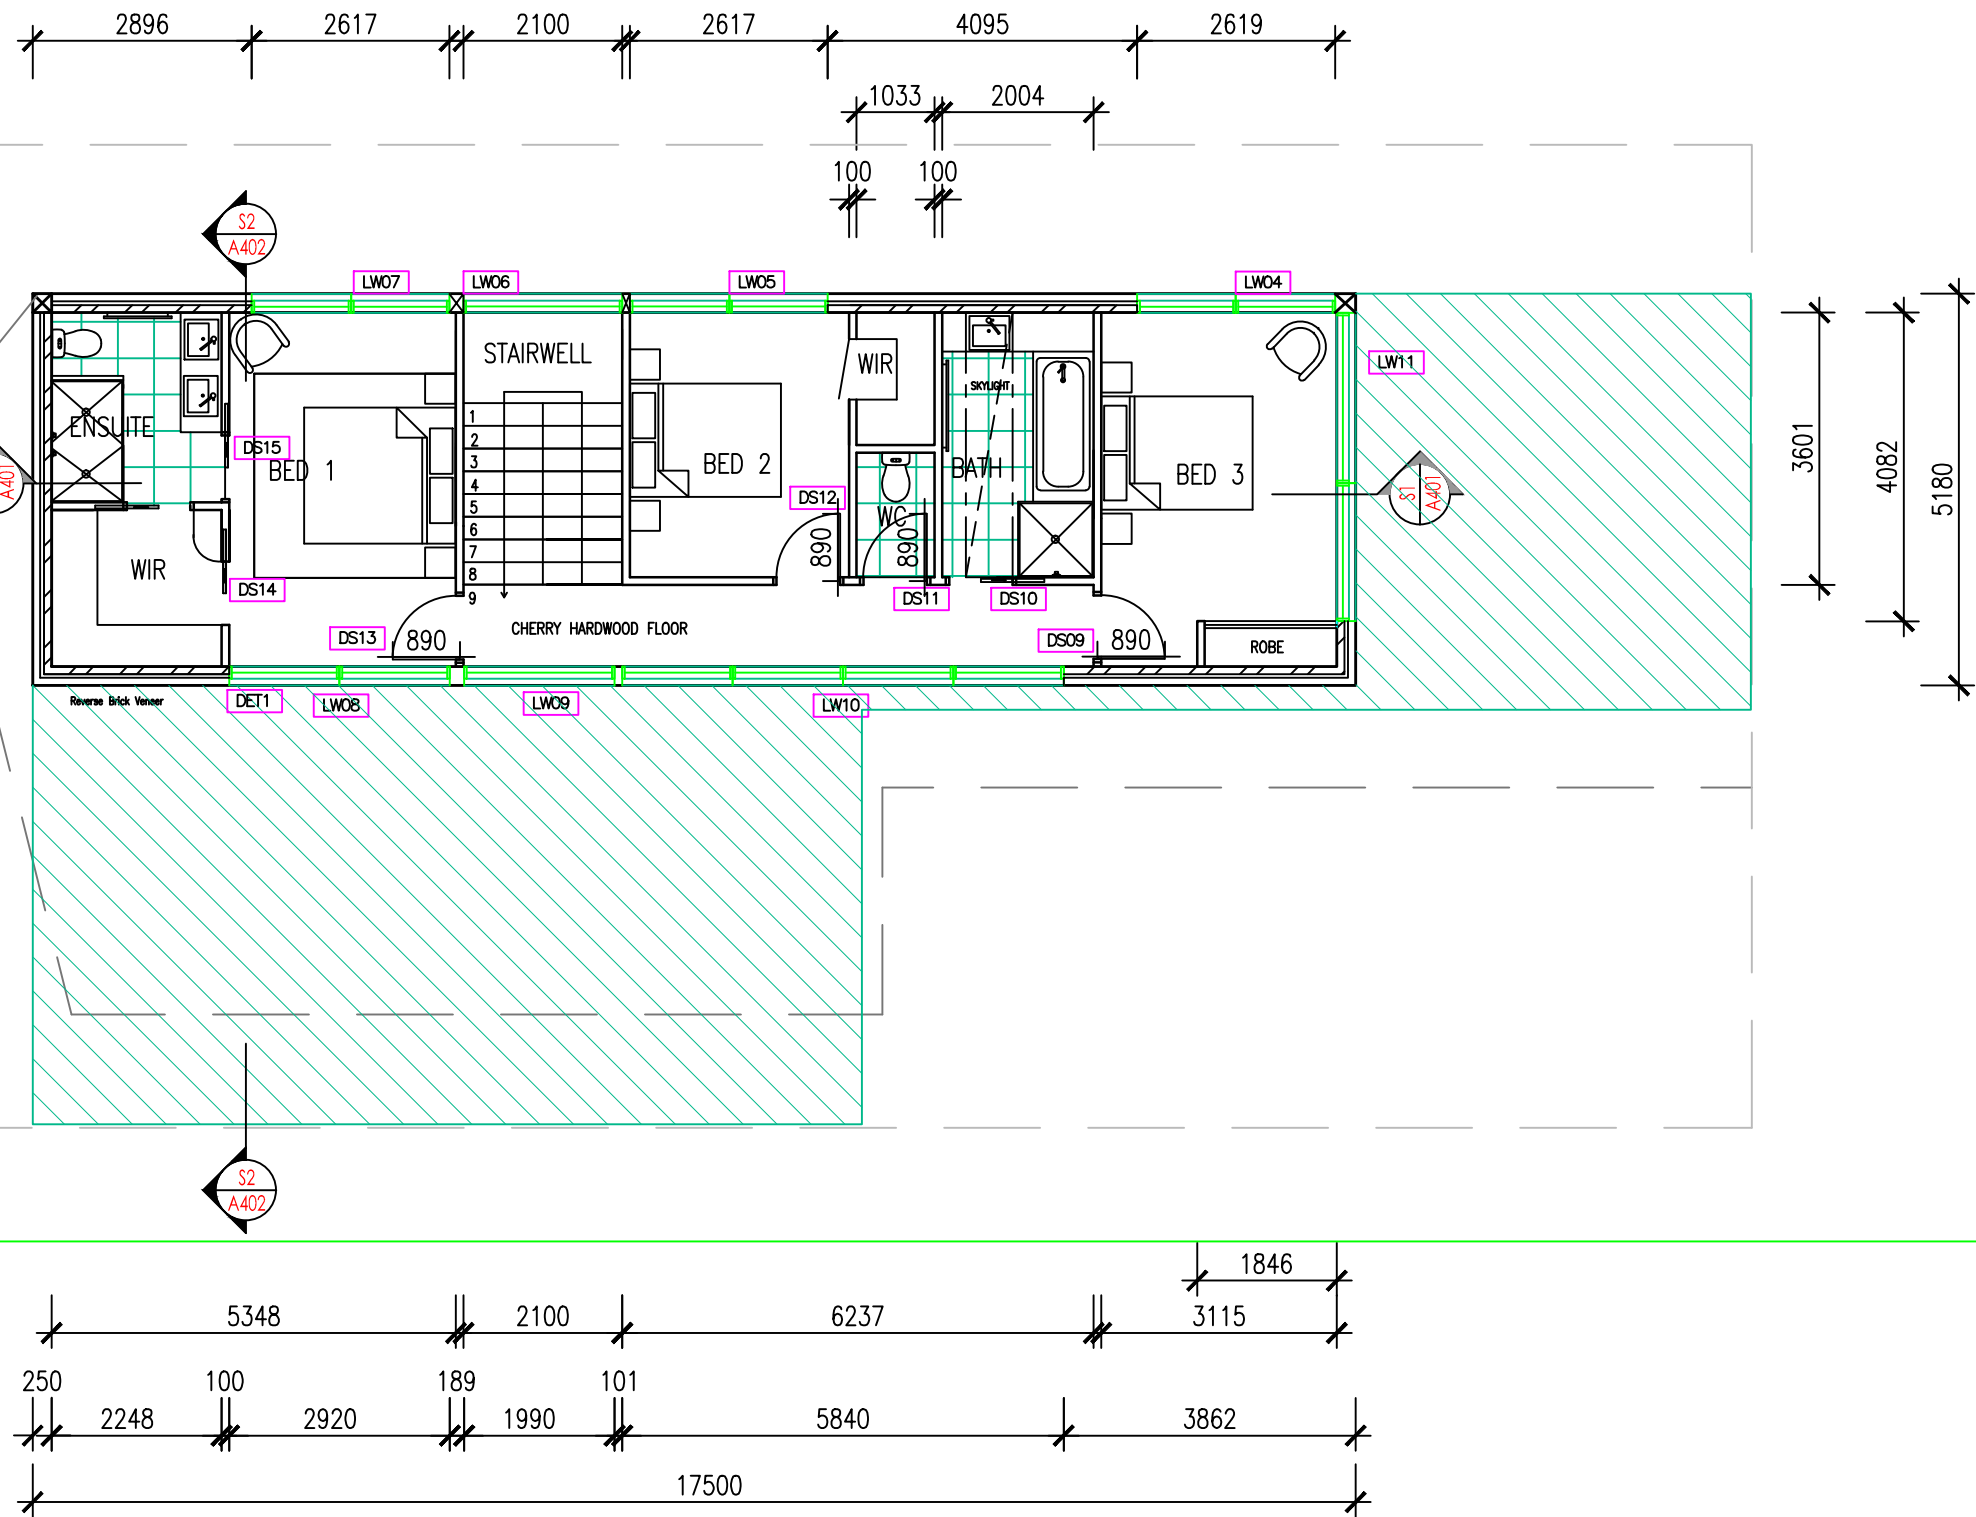

 

This document is and shall remain the property of
Geoffrey Schier
This document may only be used for the purpose for which it was commissioned \$ in accordance with the terms of engagement for the commission.
Unauthorised use of this document in anyway is prohibited. (c)

Company Details &
Logo

The logo for Treelight Design is enclosed in a thin black rectangular border. It features a stylized tree with several dark, wavy lines representing branches. Four bright yellow squares are positioned along these branches, serving as leaves. Below the tree, the words "TREELIGHT DESIGN" are written in a black, serif, all-caps font.

Client Details
AJ Bala
Block 1 Section 67
(589 sqm)

Project Name	Residential Development - Casey
--------------	---------------------------------

Drawing Title
Roof Plan

Scale 1:100	Date 18.06.14	Drawing No.
Project No. A1	Issue 1	A203



FRONT GROUND FLOOR	OFF WHITE RENDER
FRONT SECOND FLOOR	RECYCLED TIMBER VERTICAL CLADDING
REAR GROUND FLOOR	CONCRETE WALL (POLISHED INTERNAL)


Figured Dimensions to be used in preference to scaled measurements.
Contractor must verify all dimensions on site.

Copyright:
This document is and shall remain the property of **Geoffrey Schier**
This document may only be used for the purpose for which it was commissioned \$ in accordance with the terms of engagement for the commission.
Unauthorised use of this document in anyway is prohibited. (c)

Amendments		
No	Description	Date

Drawn By Geoffrey Schier	Verified By AJ Bala
Designed By CIT	Date Drawn 30.05.2014
Authorised By	

Company Details & Logo




Client Details
AJ Bala
Block 1 Section 67
(589 sqm)

Project Name
Residential Development - Casey

Drawing Title
South Elevation


Scale 1:100	Date 18.06.14	Drawing No.
Project No. A1	Issue 1	A301

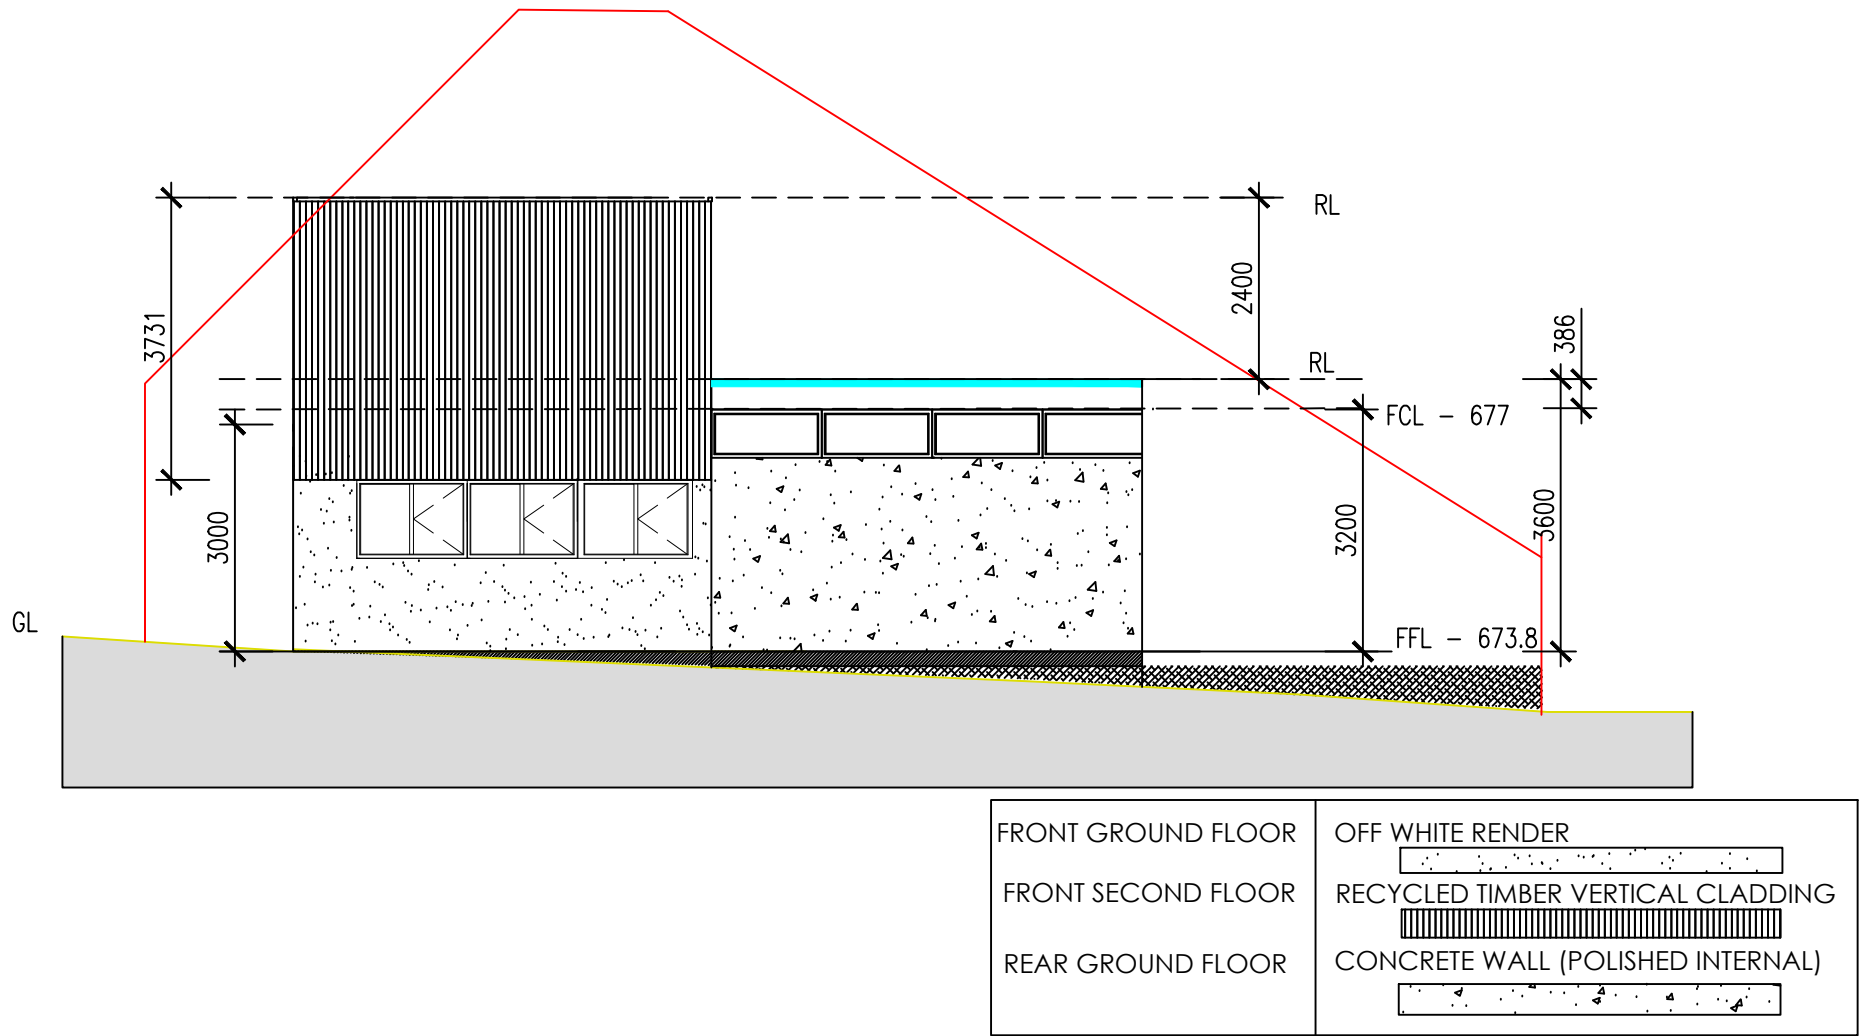


Figured Dimensions to be used in preference to scaled measurements.
Contractor must verify all dimensions on site.

Copyright:
This document is and shall remain the property of **Geoffrey Schier**
This document may only be used for the purpose for which it was commissioned \$ in accordance with the terms of engagement for the commission.
Unauthorised use of this document in anyway is prohibited. (c)

Amendments		
No	Description	Date

Drawn By Geoffrey Schier	Verified By AJ Bala	
Designed By CIT	Date Drawn 30.05.2013	
Authorised By		
Company Details & Logo		
 TREELIGHT DESIGN		
Client Details AJ Bala Block 1 Section 67 (589 sqm)		
Project Name Residential Development - Casey		
Drawing Title West Elevation		
Scale 1:100	Date 18.06.14	Drawing No.
Project No. A1	Issue 1	A302

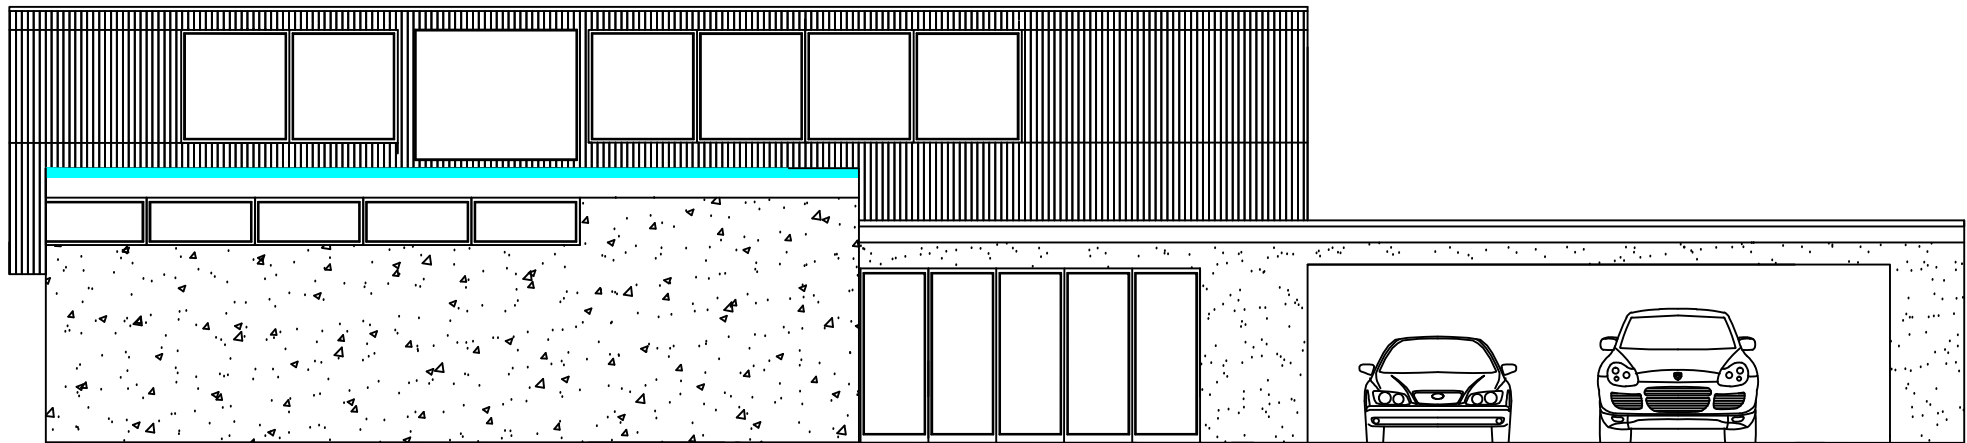

FRONT GROUND FLOOR	OFF WHITE RENDER
FRONT SECOND FLOOR	RECYCLED TIMBER VERTICAL CLADDING
REAR GROUND FLOOR	CONCRETE WALL (POLISHED INTERNAL)


Figured Dimensions to be used in preference to scaled measurements.
Contractor must verify all dimensions on site.

Copyright:
This document is and shall remain the property of **Geoffrey Schier**
This document may only be used for the purpose for which it was commissioned \$ in accordance with the terms of engagement for the commission.
Unauthorised use of this document in anyway is prohibited. (c)

Amendments		
No	Description	Date

Drawn By Geoffrey Schier	Verified By AJ Bala
Designed By CIT	Date Drawn 30.05.2014
Authorised By	

Company Details & Logo



TREELIGHT DESIGN

Client Details
AJ Bala
Block 1 Section 67
(589 sqm)

Project Name
Residential Development - Casey

Drawing Title
North Elevation

Scale 1:100	Date 18.06.14	Drawing No.
Project No. A1	Issue 1	A302

Figured Dimensions to be used in preference to scaled measurements.
Contractor must verify all dimensions on site.


Copyright:
This document is and shall remain the property of **Geoffrey Schier**
This document may only be used for the purpose for which it was commissioned \$ in accordance with the terms of engagement for the commission.
Unauthorised use of this document in anyway is prohibited. (c)

Amendments		
No	Description	Date

Drawn By Geoffrey Schier	Verified By AJ Bala
Designed By CIT	Date Drawn 5.06.2014

Authorised By

Company Details & Logo




TREELIGHT DESIGN



Client Details
AJ Bala
Block 1 Section 67
(589 sqm)

Project Name
Residential Development - Casey

Drawing Title
Section 1

Scale 1:65	Date 18.06.14	Drawing No.
Project No. A1	Issue 1	A401

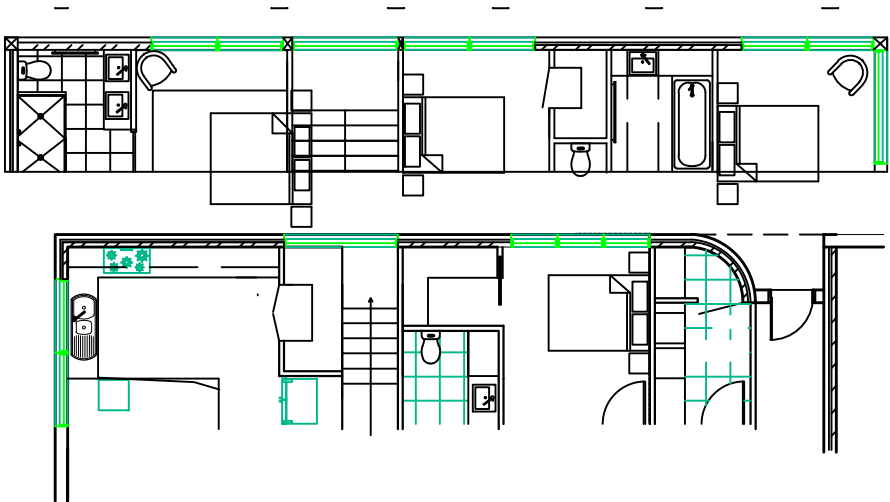

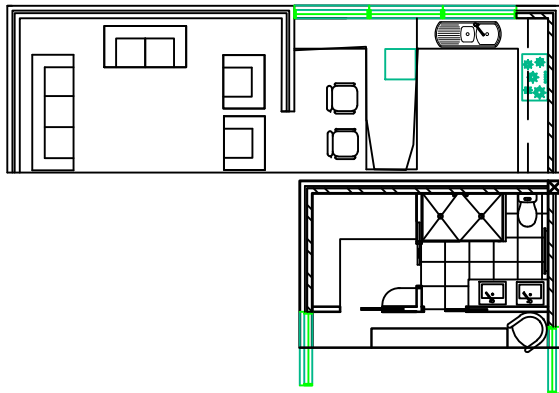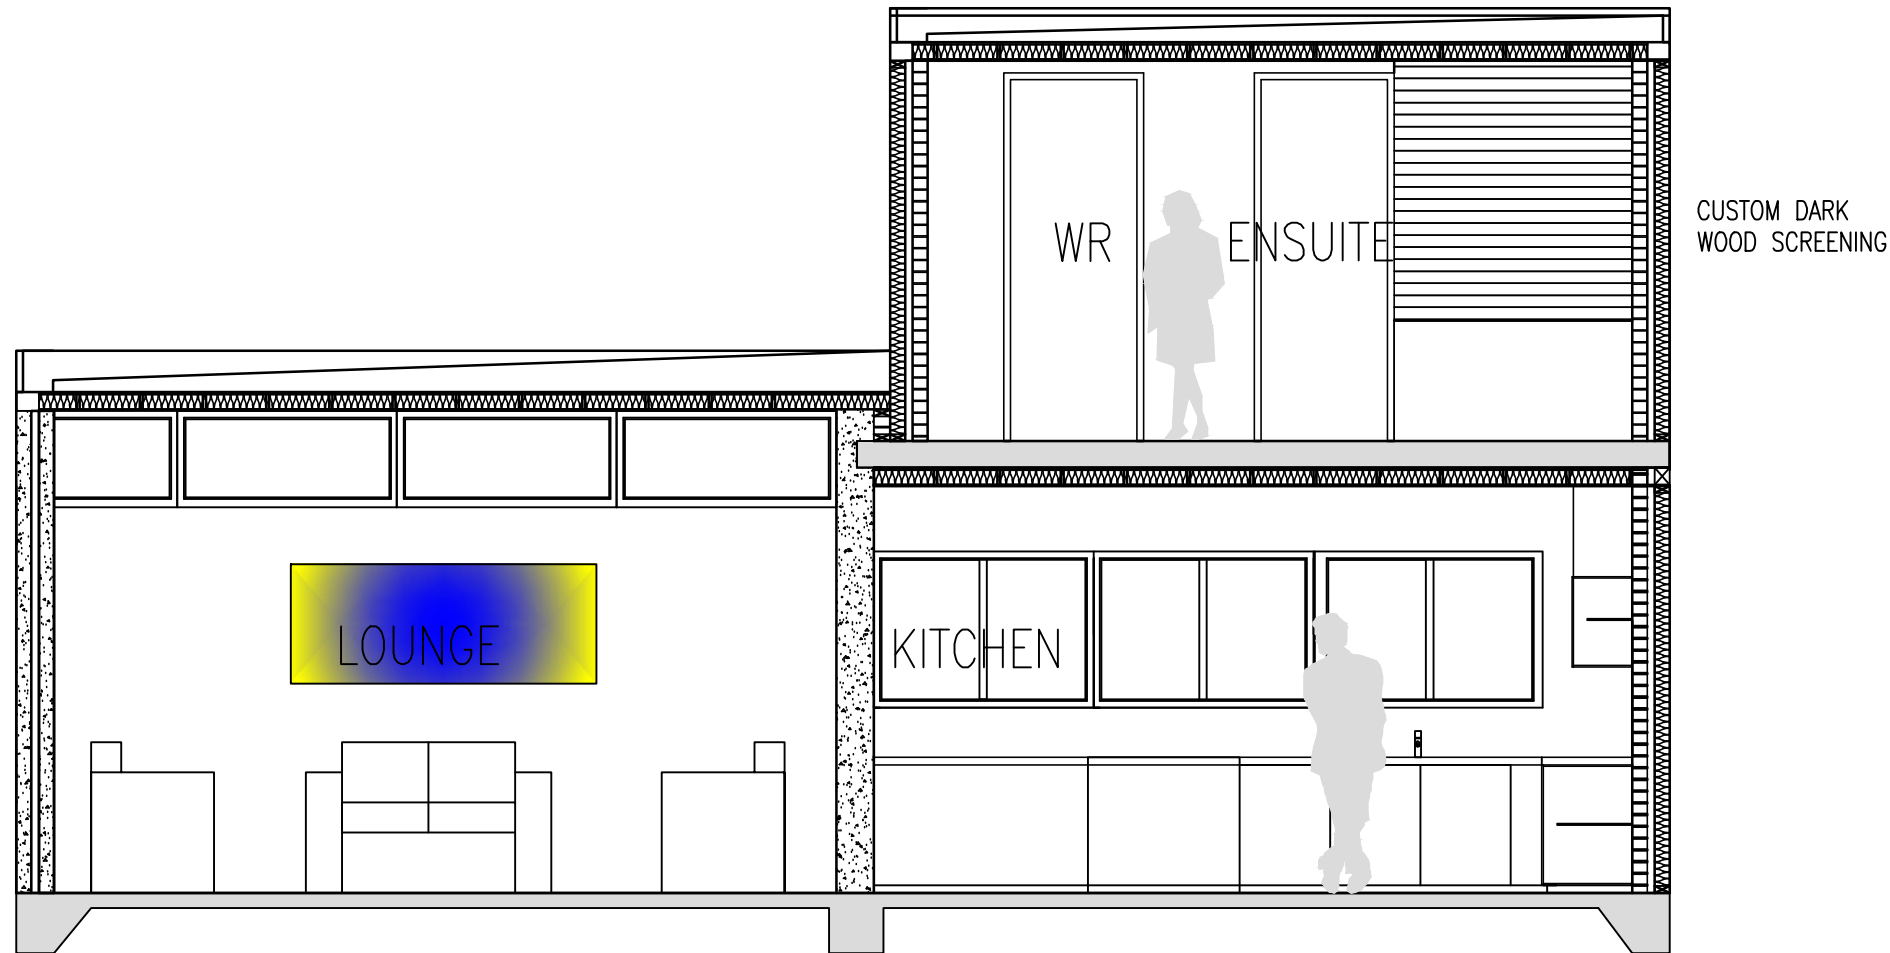

Figured Dimensions to be used in preference to scaled measurements.
Contractor must verify all dimensions on site.

Copyright:
This document is and shall remain the property of **Geoffrey Schier**
This document may only be used for the purpose for which it was commissioned \$ in accordance with the terms of engagement for the commission.
Unauthorised use of this document in anyway is prohibited. (c)

Amendments		
No	Description	Date

Drawn By Geoffrey Schier	Verified By AJ Bala
-----------------------------	------------------------

Designed By CIT	Date Drawn 30.06.2014
--------------------	--------------------------

Authorised By

Company Details &
Logo




Client Details
AJ Bala
Block 1 Section 67
(589 sqm)

Project Name
Residential Development - Casey

Drawing Title
Section 2

Scale 1:50	Date 18.06.14	Drawing No.
Project No. A1	Issue 1	A402

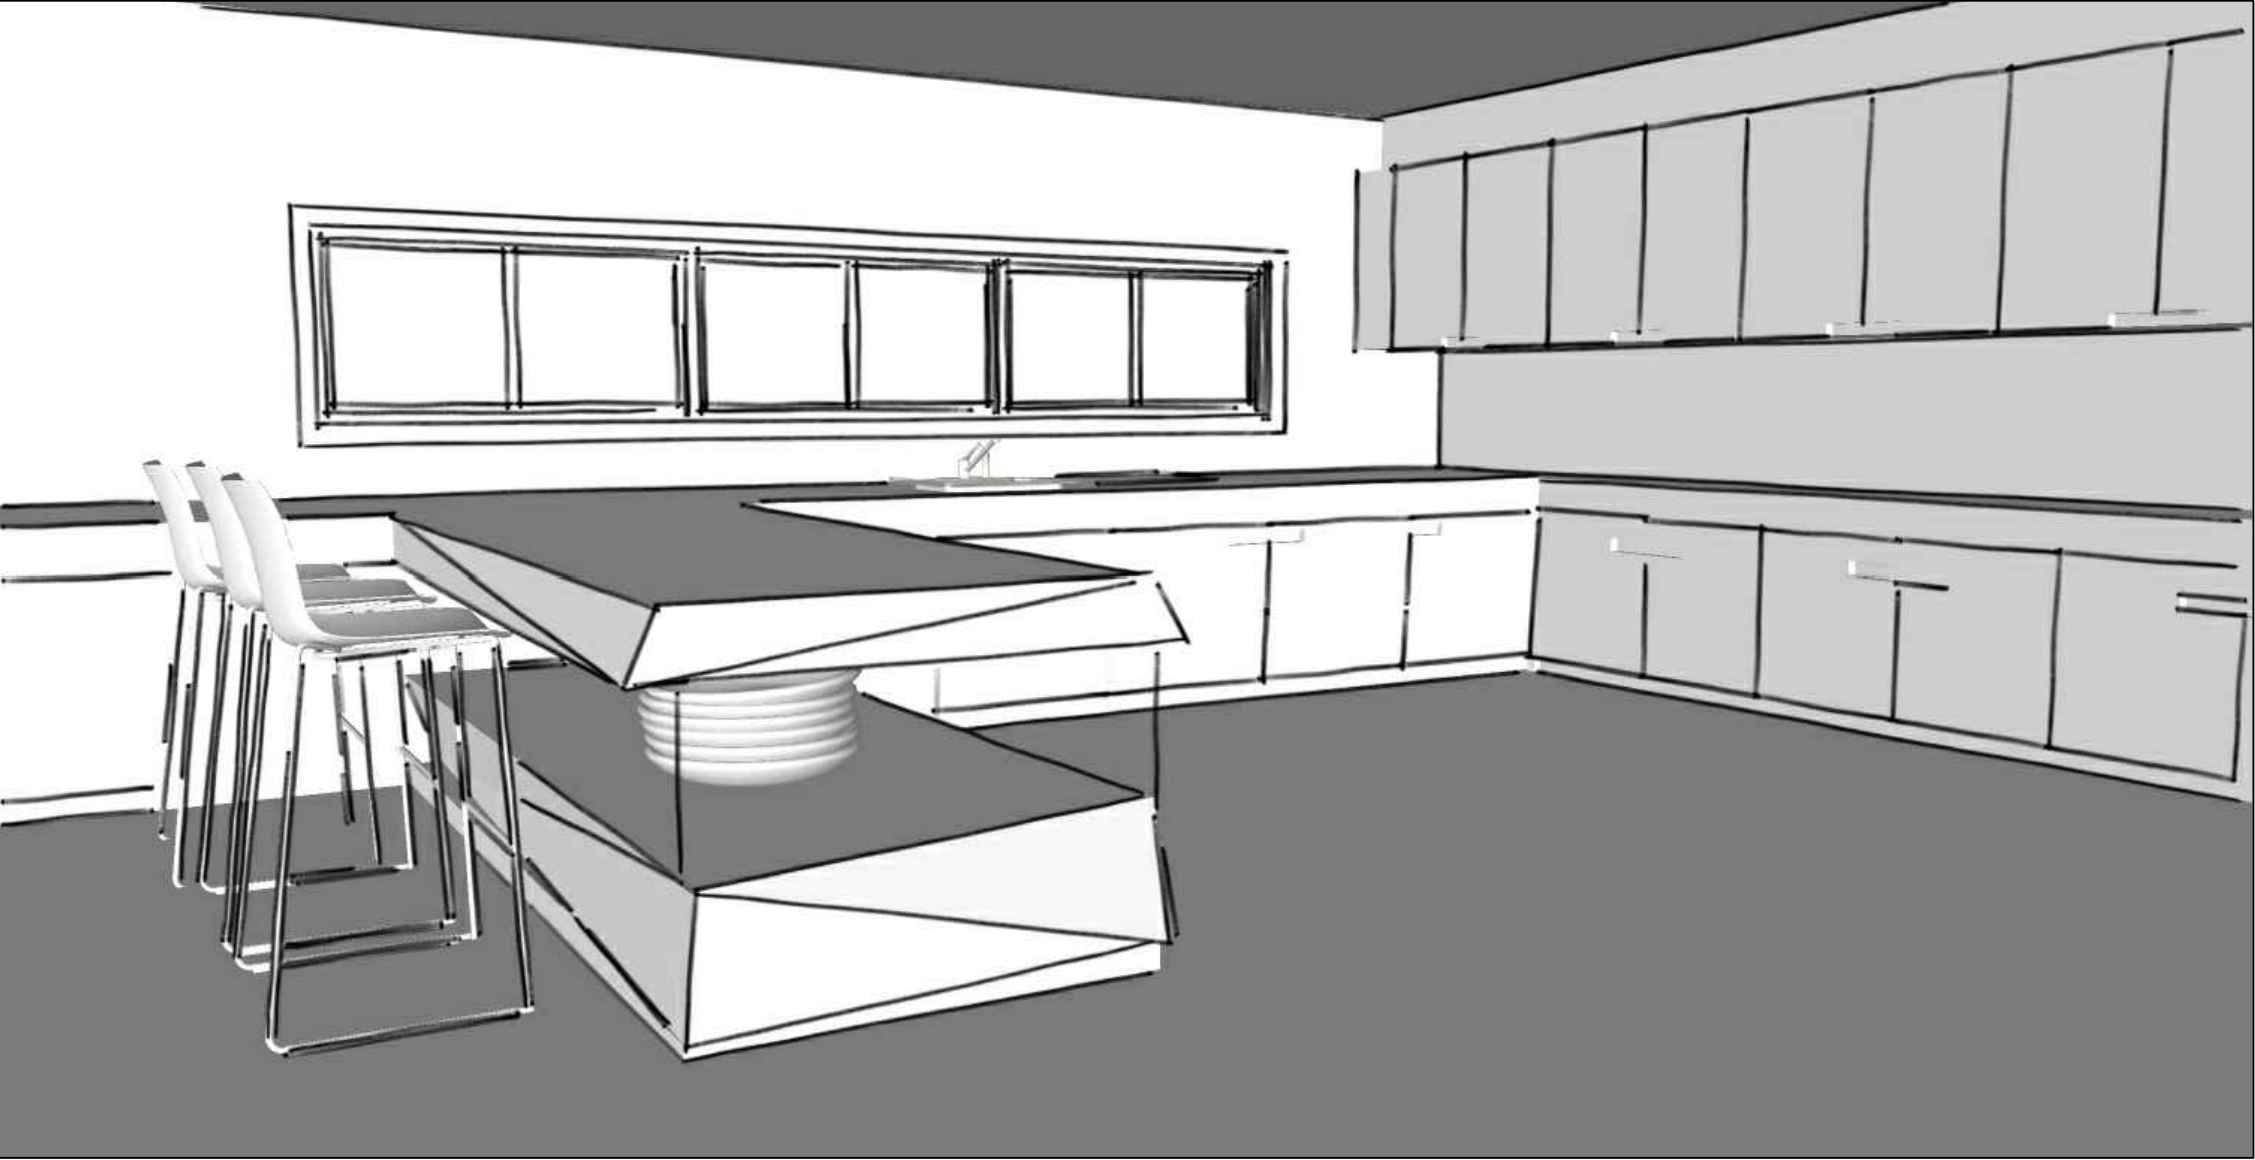

Figured Dimensions to be used in preference to scaled measurements.
Contractor must verify all dimensions on site.

Copyright:
This document is and shall remain the property of **Geoffrey Schier**
This document may only be used for the purpose for which it was commissioned \$ in accordance with the terms of engagement for the commission.
Unauthorised use of this document in anyway is prohibited. (c)


Amendments		
No	Description	Date

Drawn By Geoffrey Schier	Verified By AJ Bala
-----------------------------	------------------------

Designed By CIT	Date Drawn 30.05.2014
--------------------	--------------------------

Authorised By

Company Details & Logo



TREELIGHT DESIGN

Client Details AJ Bala Block 1 Section 67 (589 sqm)
--

Project Name Residential Development - Casey

Drawing Title Kitchen Detail

Scale 1:20	Date 18.06.14	Drawing No.
Project No. A1	Issue 1	A502

Figured Dimensions to be used in preference to scaled measurements.
Contractor must verify all dimensions on site.


Copyright:
This document is and shall remain the property of **Geoffrey Schier**
This document may only be used for the purpose for which it was commissioned \$ in accordance with the terms of engagement for the commission.
Unauthorised use of this document in anyway is prohibited. (c)

Amendments		
No	Description	Date

Drawn By Geoffrey Schier	Verified By AJ Bala
Designed By CIT	Date Drawn 30.05.2014

Authorised By

Company Details & Logo





TREELIGHT DESIGN

Client Details
AJ Bala
Block 1 Section 67
(589 sqm)


Project Name
Residential Development - Casey

Drawing Title
Wall Detail

Scale 1:20	Date 18.06.14	Drawing No.
Project No. A1	Issue 1	A501

 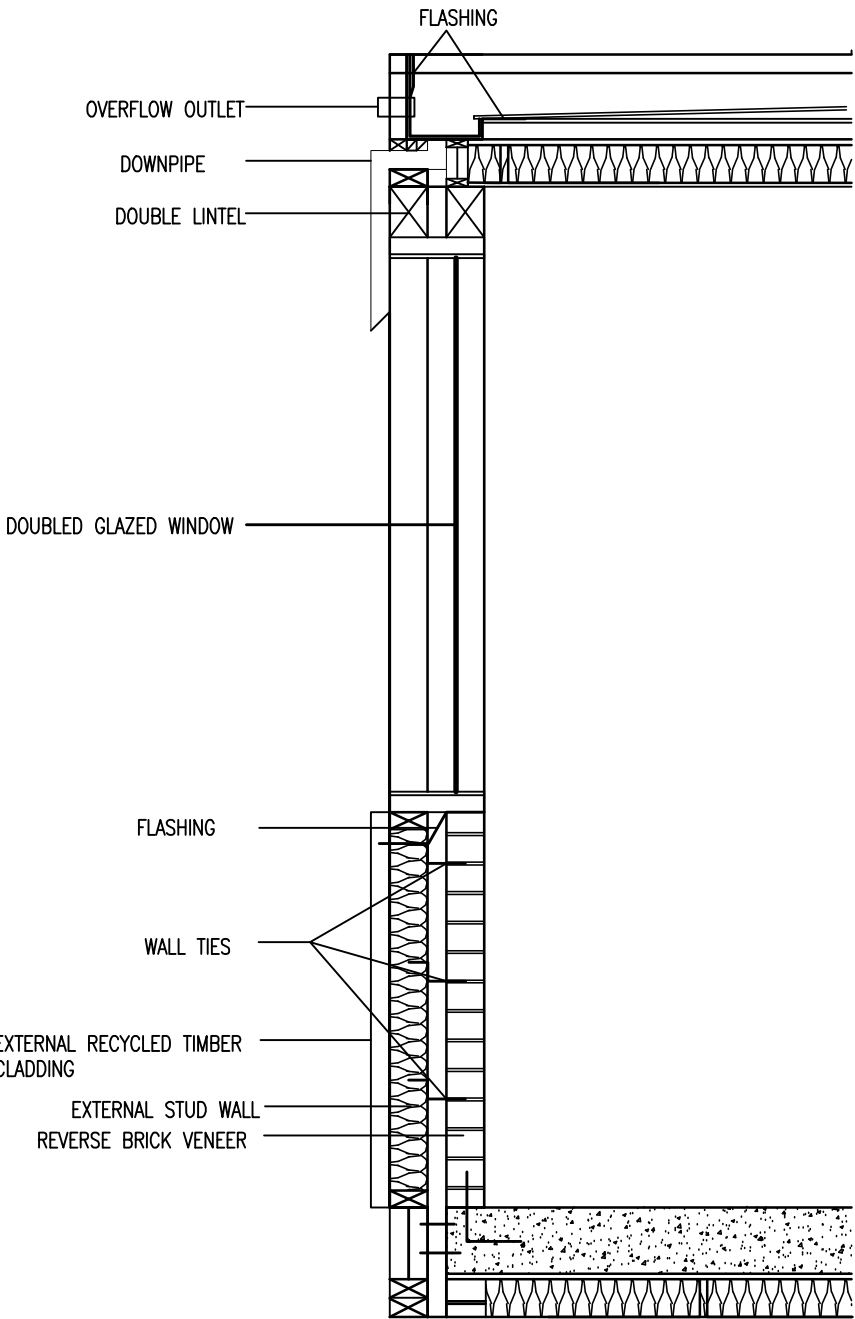

 
REVERSE BRICK VENEER (GROUND)
- EXTERNAL STUD WALL WITH INTERNAL SINGLE BRICK VENEER AND EXTERNAL RENDERED FINISH

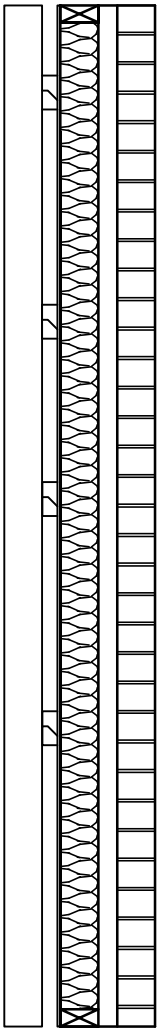






 
 
 












REVERSE BRICK VENEER (UPPER)
- EXTERNAL STUD WALL WITH INTERNAL SINGLE BRICK VENEER AND EXTERNAL RECYCLED TIMBER VERTICAL CLADDING





INTERNAL STUD WALL



 CAST CONCRETE WALL
- DOUBLE SKIN CEMENT WALL WITH INTERNAL INSULATION AND POLISHED CONCRETE FINISH ON ON INTERNAL SIDE

LEGEND	
	SINGLE GENERAL POWER OUTLET
	DOUBLE GENERAL POWER OUTLET
	EXTERNAL GPO
	SMOKE DETECTOR (hard wired)
	TELEPHONE POINT
	METER BOX
	CIRCUIT BREAKER BOX
	REVERSE CYCLE UNIT
	FEATURE LIGHT
	WALL LIGHT POINT
	DIGITAL CONTROL SYSTEM
	SWITCH
	DATA OUTLET
	TWO WAY SWITCH
	EXHAUST FAN
	LIGHT POINT
	FLUSH MOUNTED LIGHT POINT
	EXTERNAL WALL MOUNTED LIGHT
	GAS OUTLET
	WIRING

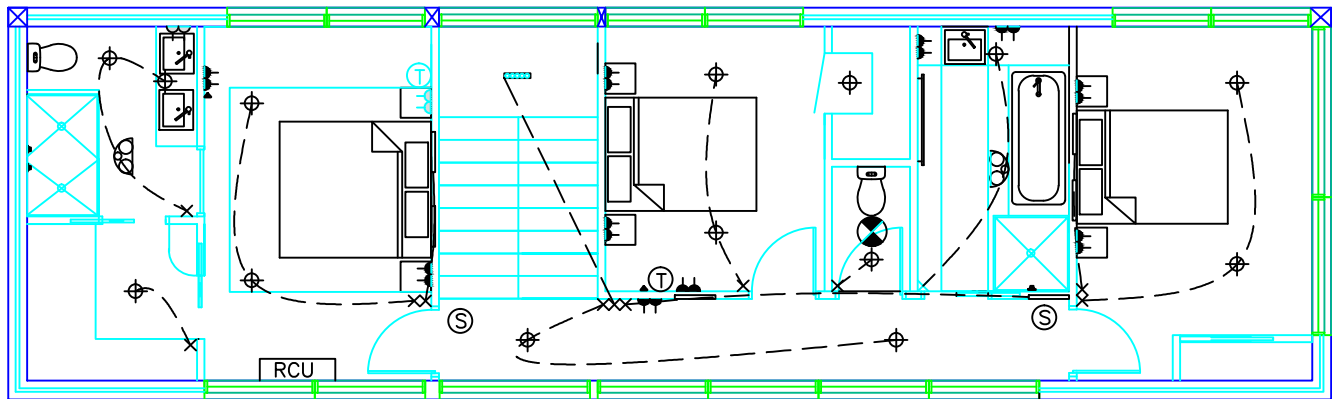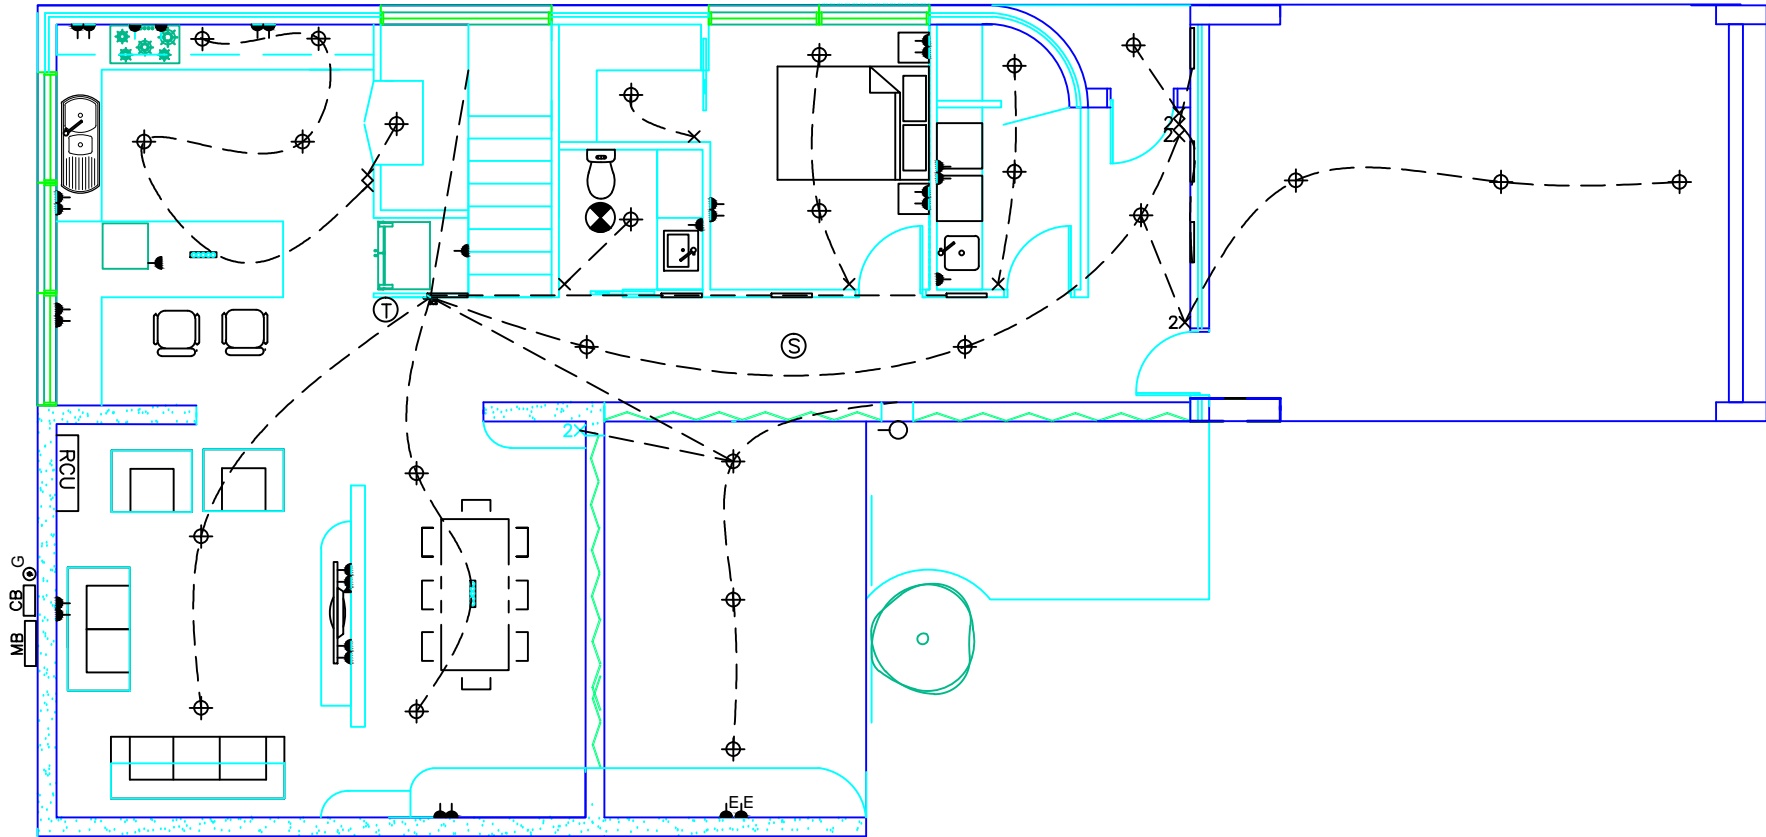

Figured Dimensions to be used in preference to scaled measurements.
Contractor must verify all dimensions on site.

Copyright:
This document is and shall remain the property of **Geoffrey Schier**
This document may only be used for the purpose for which it was commissioned \$ in accordance with the terms of engagement for the commission.
Unauthorised use of this document in anyway is prohibited. (c)

Amendments		
No	Description	Date

Drawn By Geoffrey Schier	Verified By AJ Bala
-----------------------------	------------------------

Designed By CIT	Date Drawn 30.05.2014
--------------------	--------------------------

Authorised By

Company Details & Logo




Client Details
AJ Bala
Block 1 Section 67
(589 sqm)

Project Name
Residential Development - Casey

Drawing Title
RCP/Electrical Plan

Scale 1:100	Date 18.06.14	Drawing No.
Project No. A1	Issue 1	A602

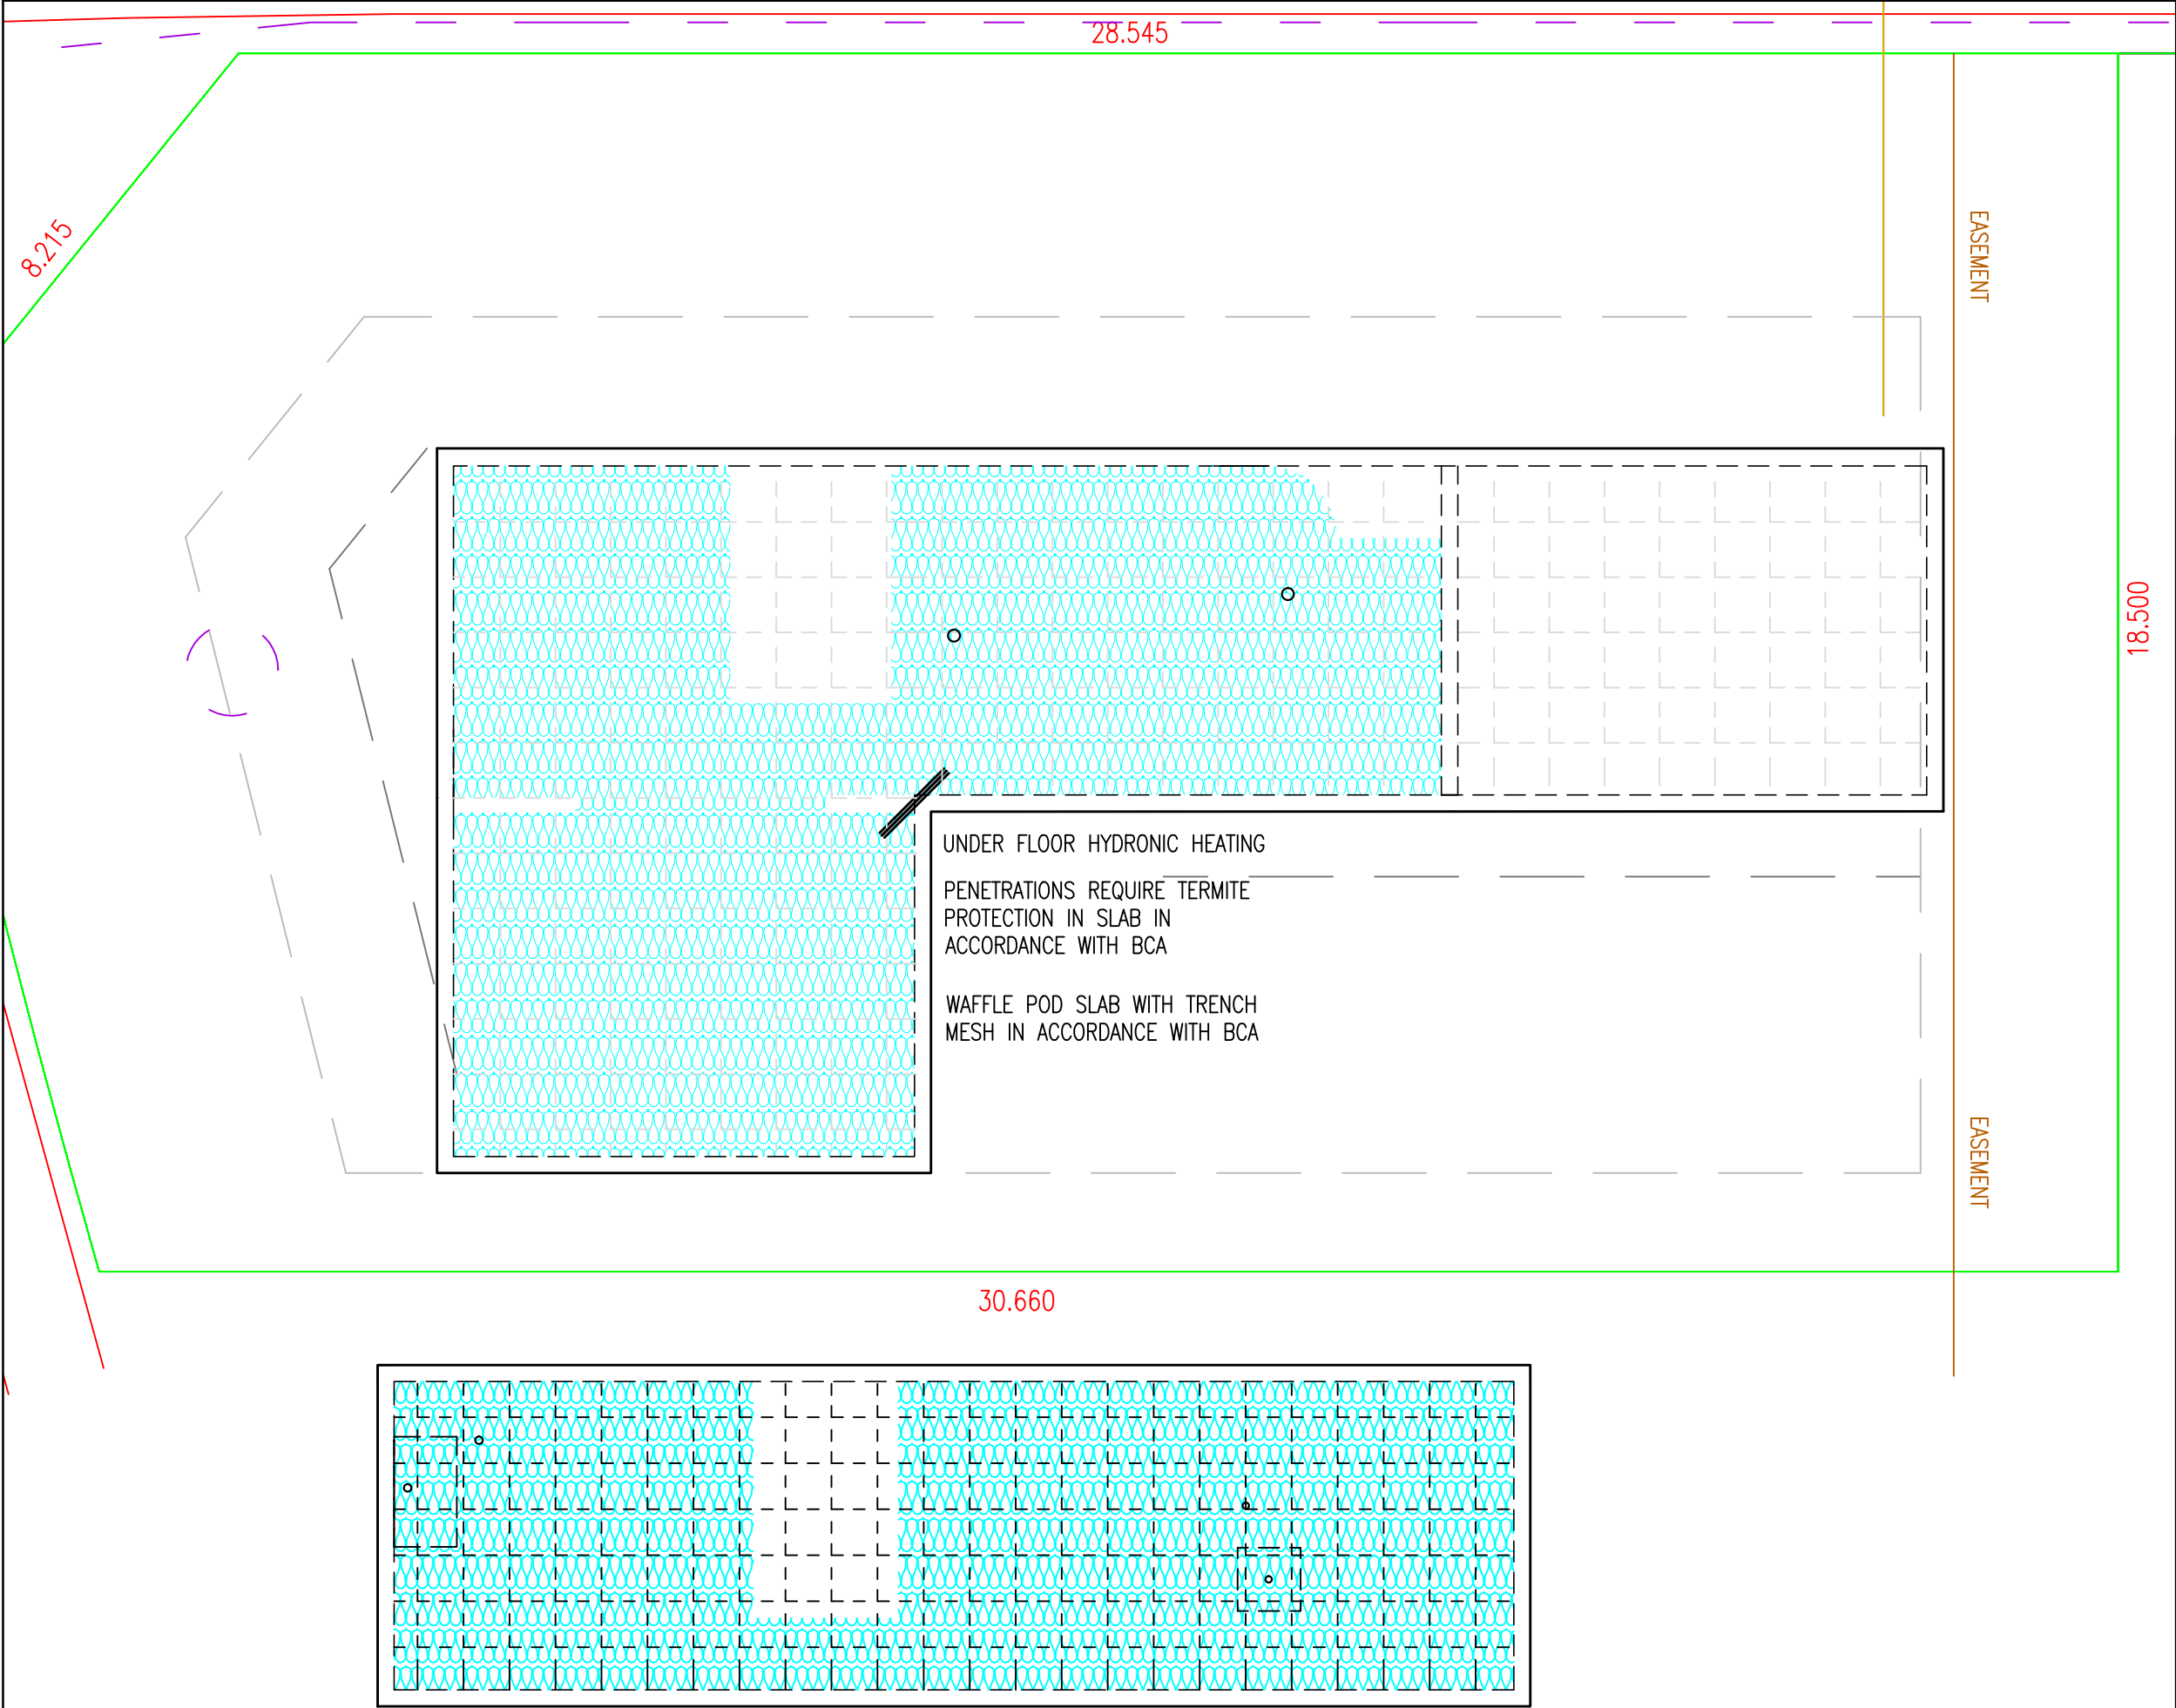

Figured Dimensions to be used in preference to scaled measurements.
Contractor must verify all dimensions on site.

Copyright:
This document is and shall remain the property of **Geoffrey Schier**
This document may only be used for the purpose for which it was commissioned \$ in accordance with the terms of engagement for the commission.
Unauthorised use of this document in anyway is prohibited. (c)


Amendments		
No	Description	Date

Drawn By Geoffrey Schier	Verified By AJ Bala
-----------------------------	------------------------

Designed By CIT	Date Drawn 30.05.2014
--------------------	--------------------------

Authorised By

Company Details & Logo



Client Details
AJ Bala Block 1 Section 67 (589 sqm)

Project Name
Residential Development - Casey

Drawing Title
Slab Setout Plan

Scale 1:100	Date 18.06.14	Drawing No.
Project No. A1	Issue 1	A601